




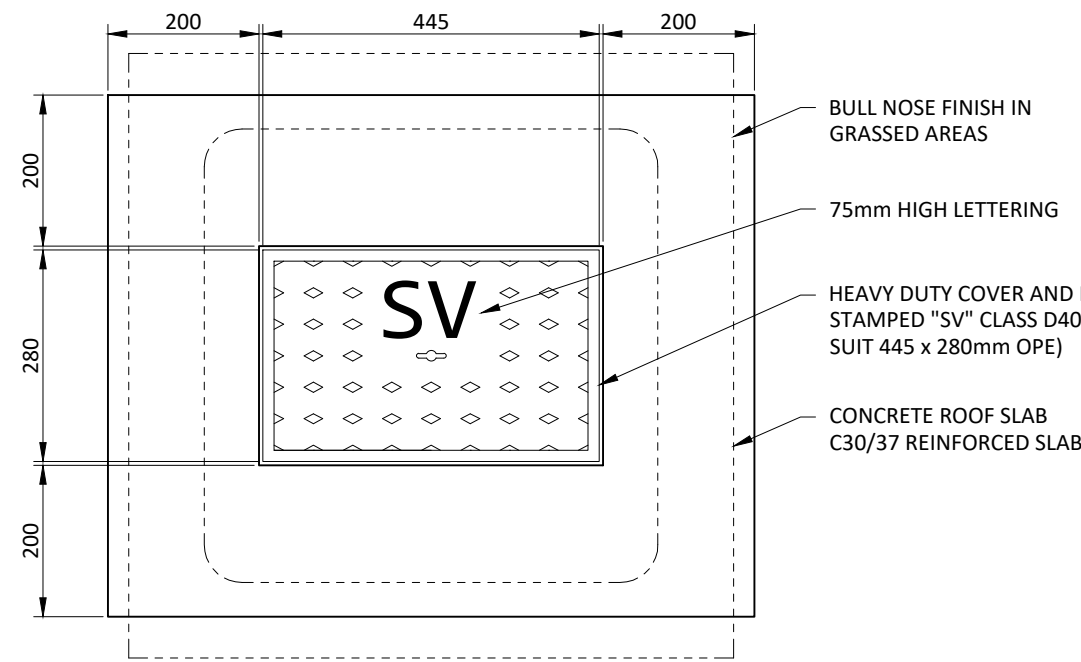


PLINTH DETAIL IN GRASSED AREAS

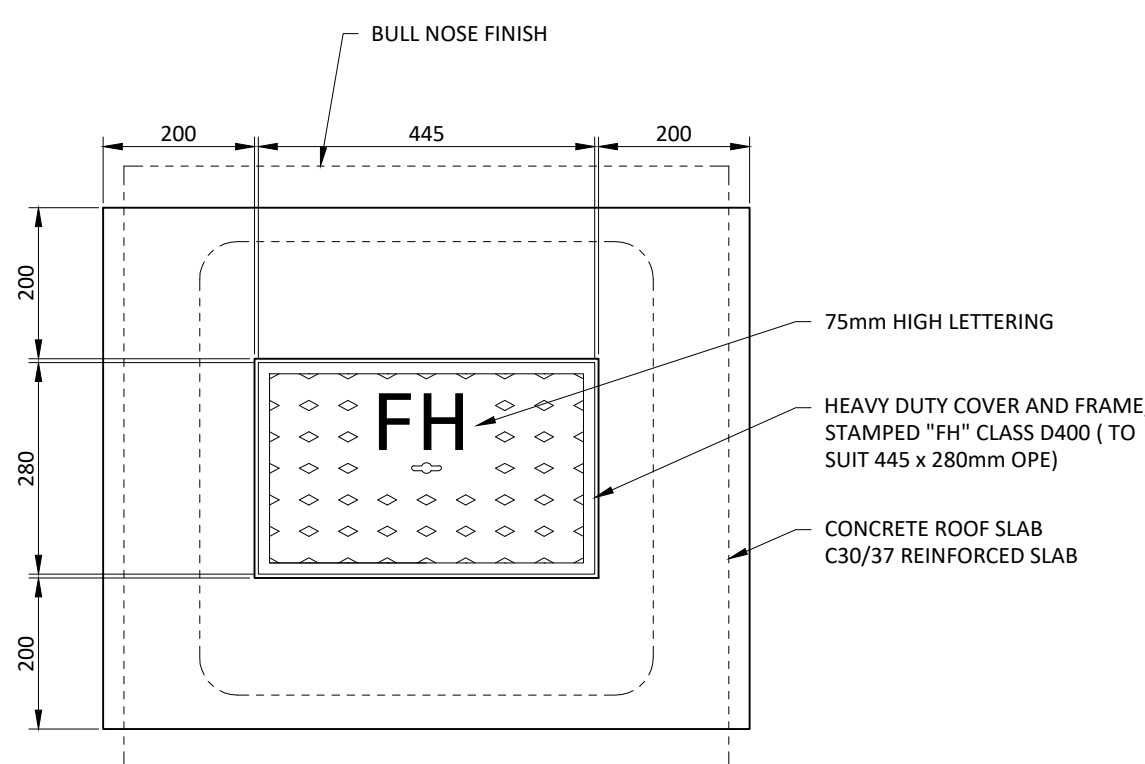


PLINTH DETAIL IN GRASSED AREAS

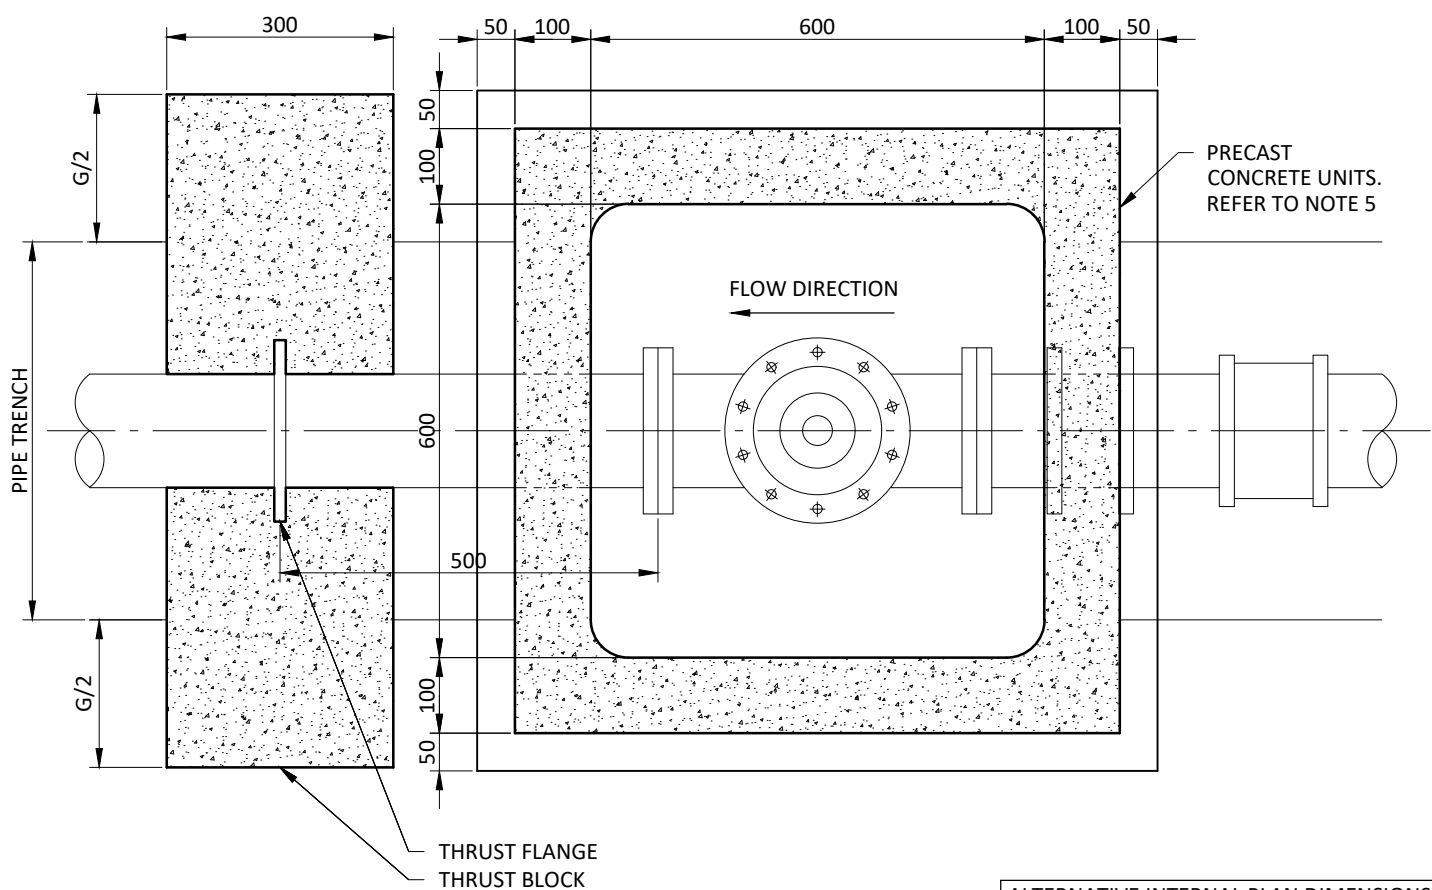

FLOOR PLAN

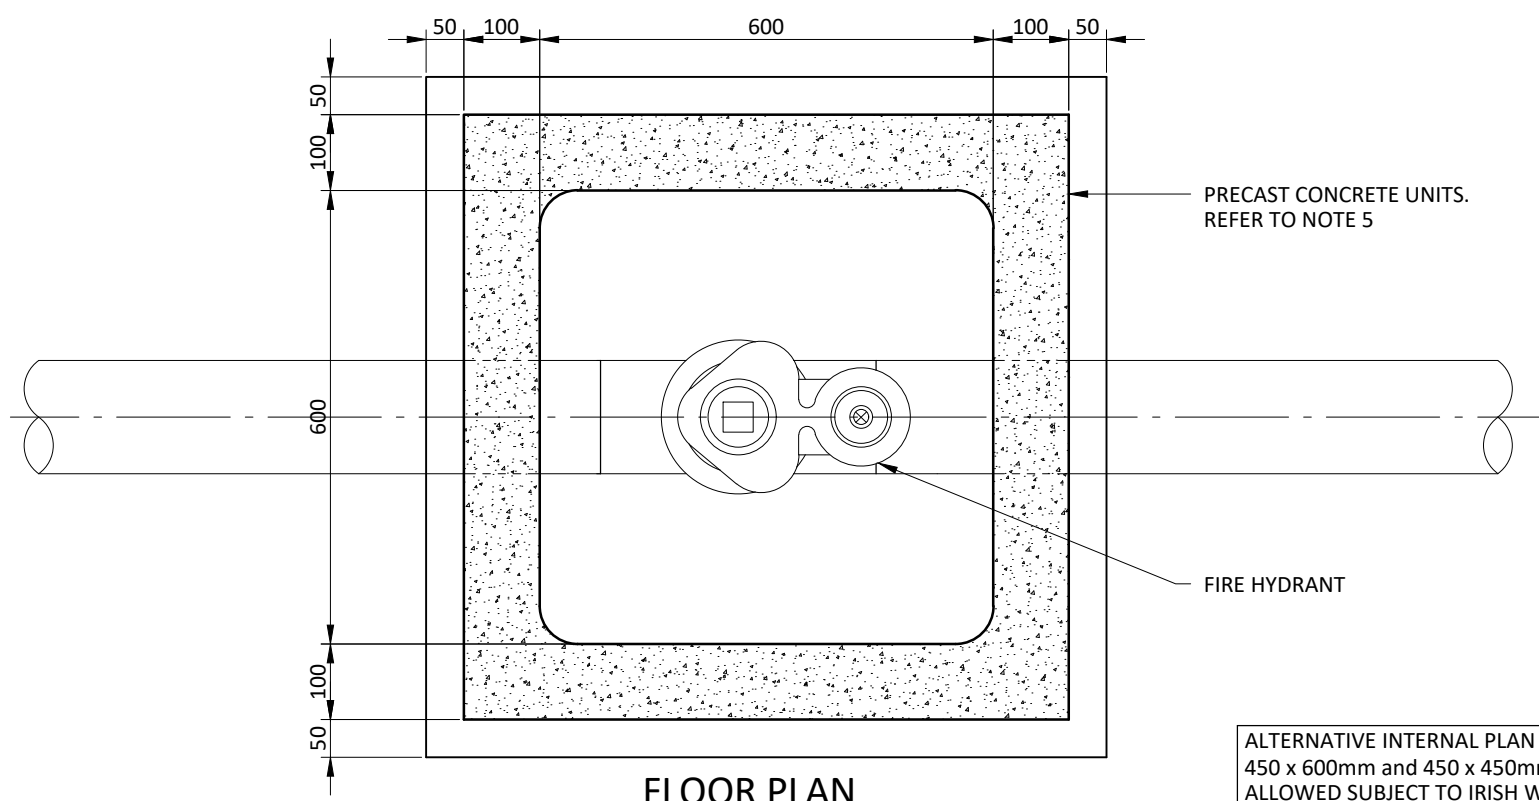


FLOOR PLAN

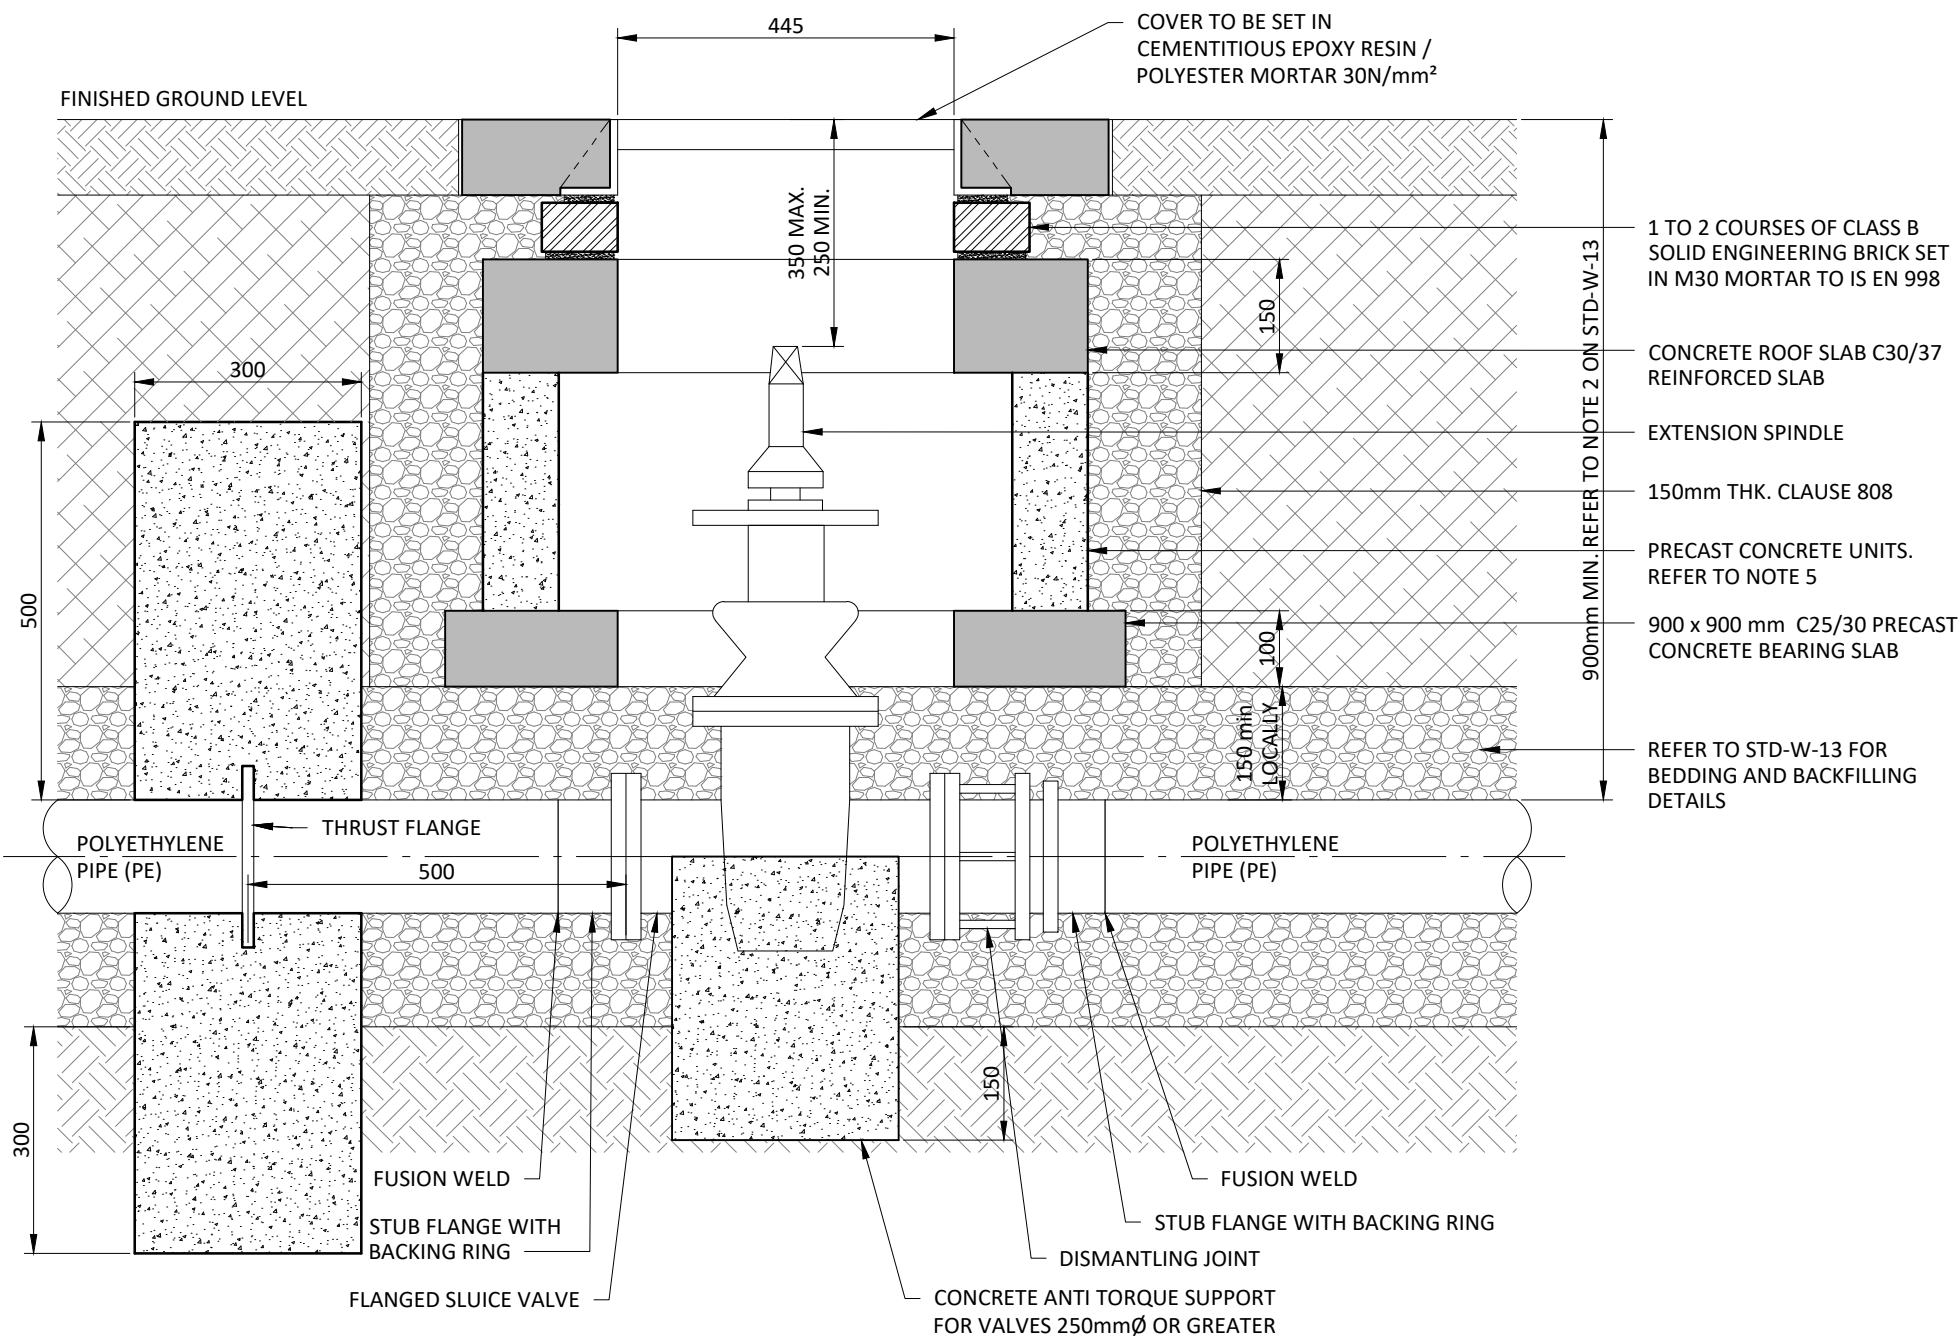

SECTION
SCALE 1:10

PRECAST SLUICE VALVE CHAMBER FOR POLYETHYLENE PIPE FROM IW-CDS-5020-01 STD-W-15 REV 3 SCALE 1:10

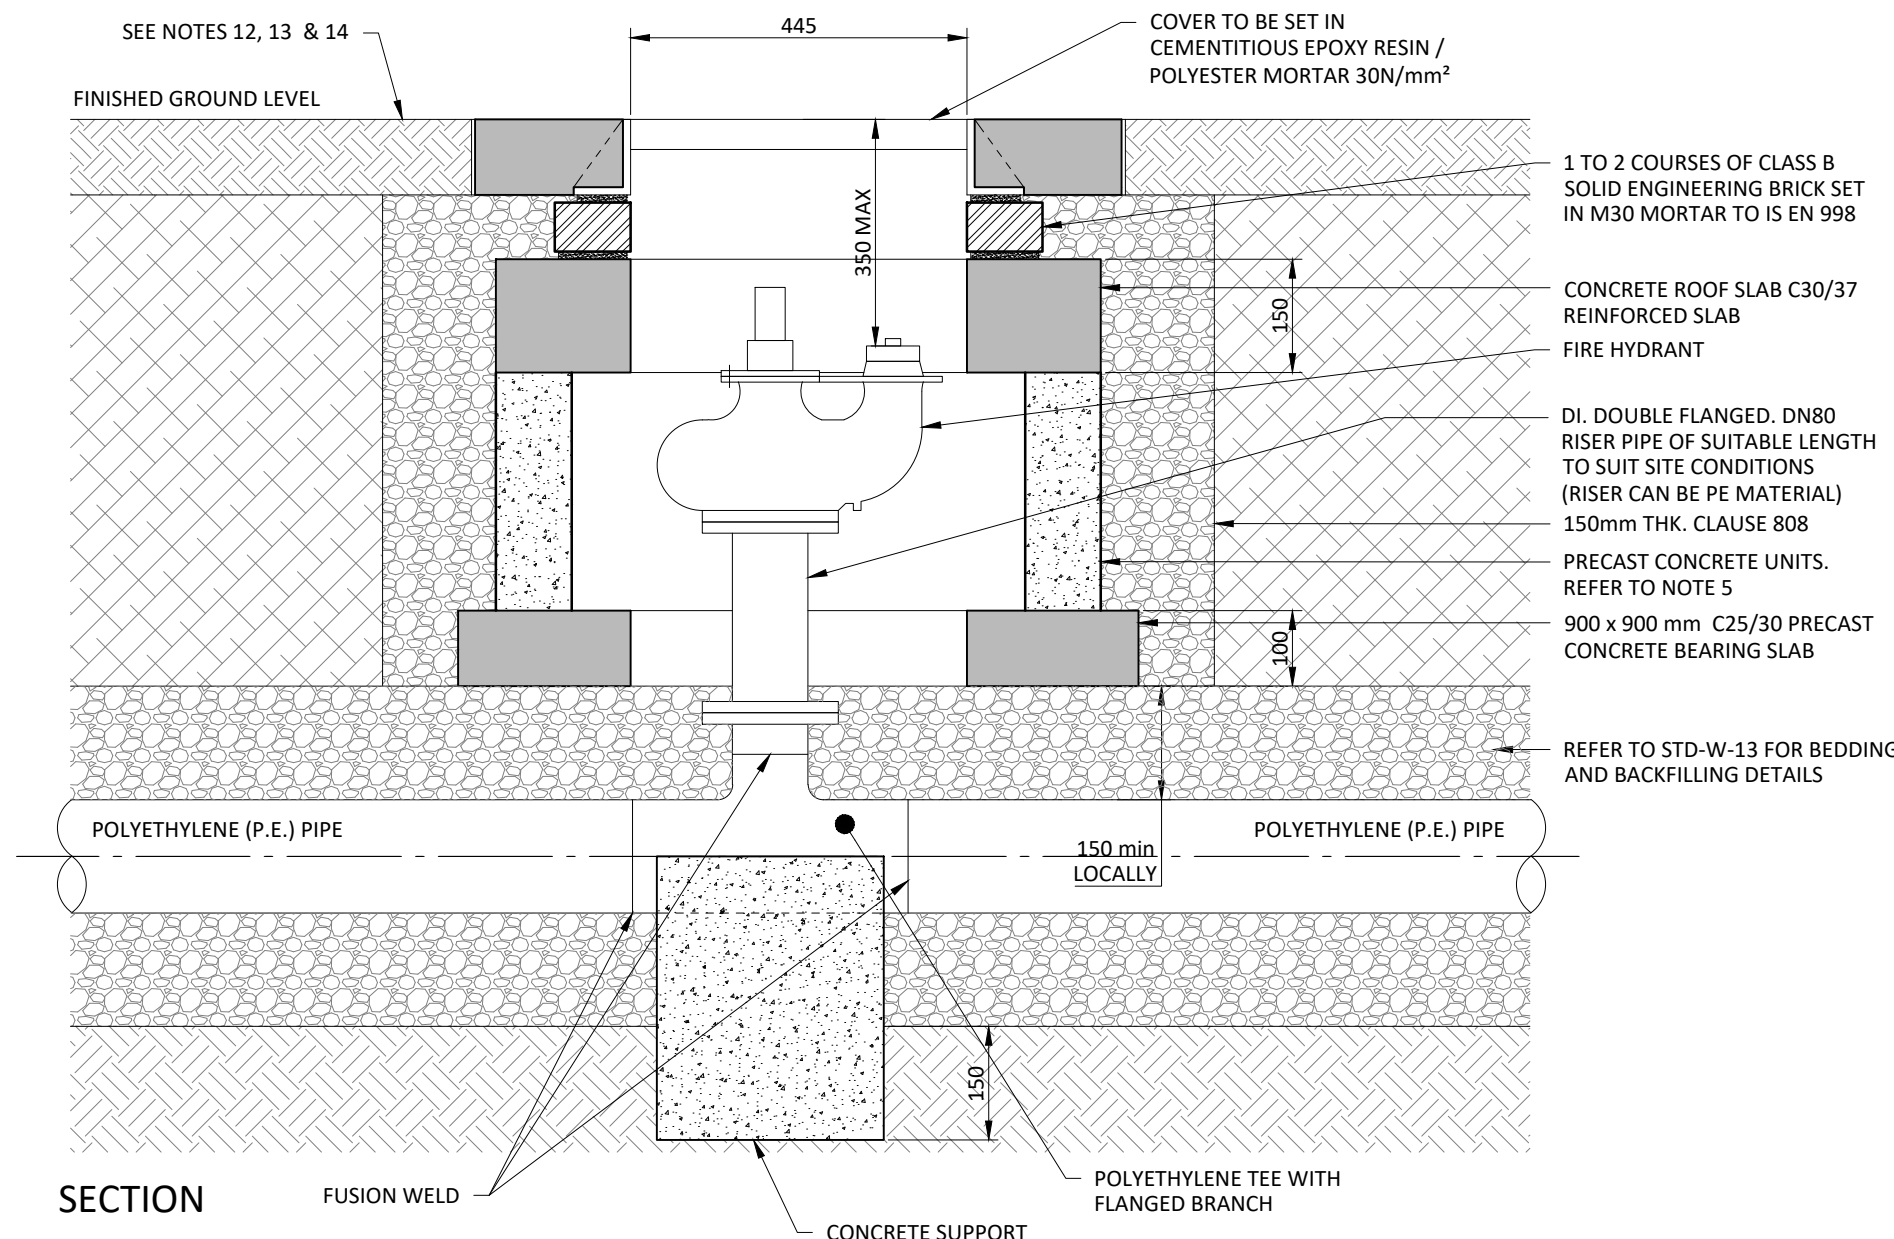

SECTION

PRECAST ON-LINE HYDRANT CHAMBER FROM IW-CDS-5020-01 STD-W-18 REV 3

SCALE 1:10

1. Do not scale from this drawing. Refer to Architects drawings for all works levels and setting out.
2. This drawing is to be read in conjunction with all other Engineer's and Architect's drawings and specifications. Where discrepancies are observed please notify CHC for clarification.
3. Contractor to check all levels (existing and proposed), setting out and dimensions on site prior to commencement of the works and advise the consultants of any discrepancies.
4. All works to be constructed in accordance with current building control legislation, local authority requirements and good building practice.
5. All insulation, weathering materials (dpc, dpm, flashings etc), radon barriers and sumps and all sub-floor ducting all to Architect's details.
6. Location of all service pop-ups to be confirmed and set out by the Architect.
7. Refer to Architect's drawings and specifications for fire strategy and all fire protection requirements
8. All materials and products specified must carry CE marking and Declarations of Performance as appropriate.
9. Contractor shall note the recommendations of the site investigation report in respect of all excavation depths, ground water levels and identification of required adequate bearing strata. All foundation formation soft spots or disturbed ground not covered in SI report to be recorded and notified to the Engineer.

FOR PLANNING

REFER TO DRAWING CHC-00-XX-DR-C-00232
FOR PIPE BEDDING DETAILS

P04	S4	15.07.2026	Issued for Planning.	P.C.	N.N.	P.C.
P03	S4	07.07.2026	Issued for Planning.	P.C.	N.N.	P.C.
P02	S4	10.11.2025	Issued for Pre-Planning.	P.C.	N.N.	P.C.
P01	S4	01.10.2025	Issued for Planning.	P.C.	N.N.	P.C.

Issue	Suitability	Date	Description	Designed	Drawn	Approved
-------	-------------	------	-------------	----------	-------	----------

Project	Conley Lands LRD, Leixlip	Drawing Title	Watermain details.			
		Sheet 2 of 5				

Client	Leixlip and Newbridge SPV Limited	Originator:	Area:	Level:	Type:	Role:	Number:
		CHC	-00	-GR	-DR	-C	-00331

--	--	--	--	--	--	--	--

--	--	--	--	--	--	--	--

--	--	--	--	--	--	--	--

--	--	--	--	--	--	--	--

--	--	--	--	--	--	--	--